
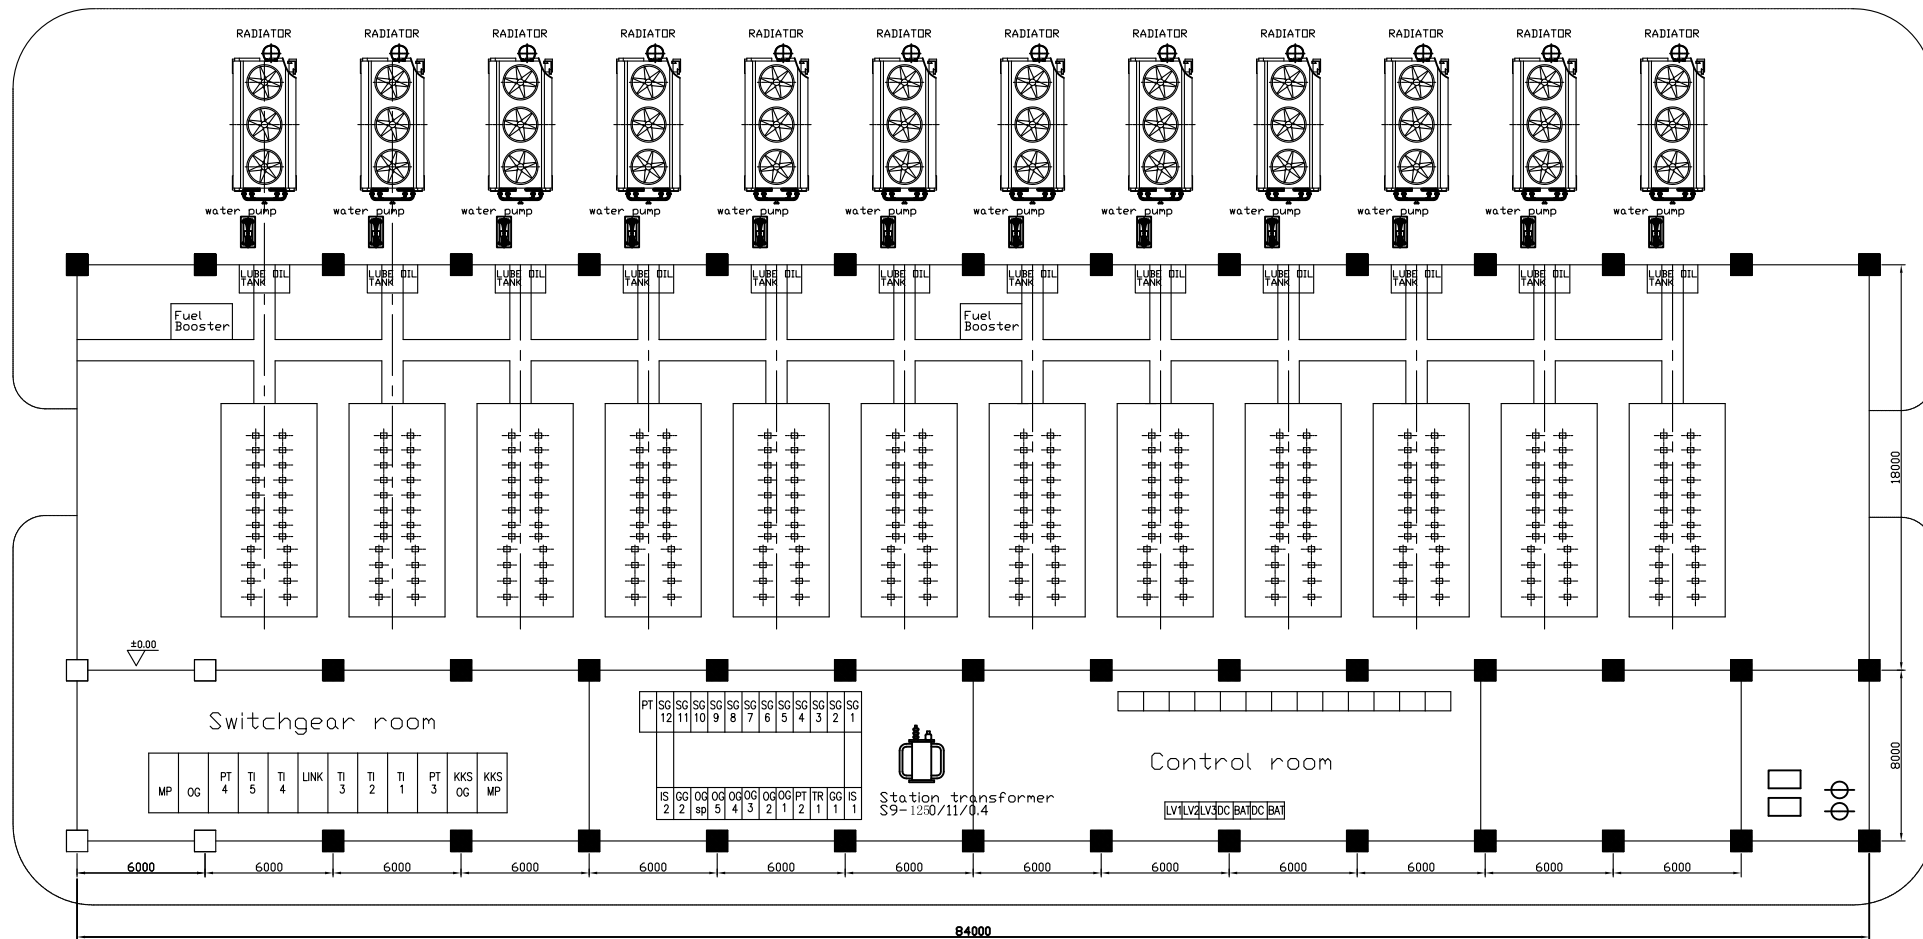
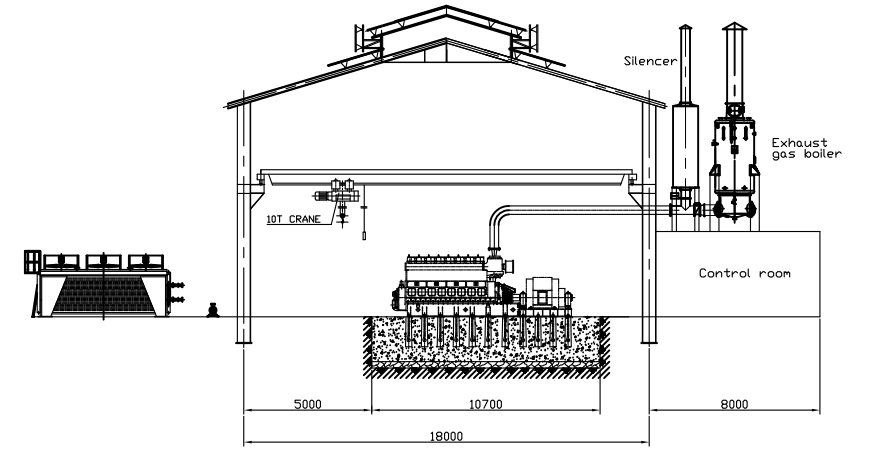


Pump and separator Room

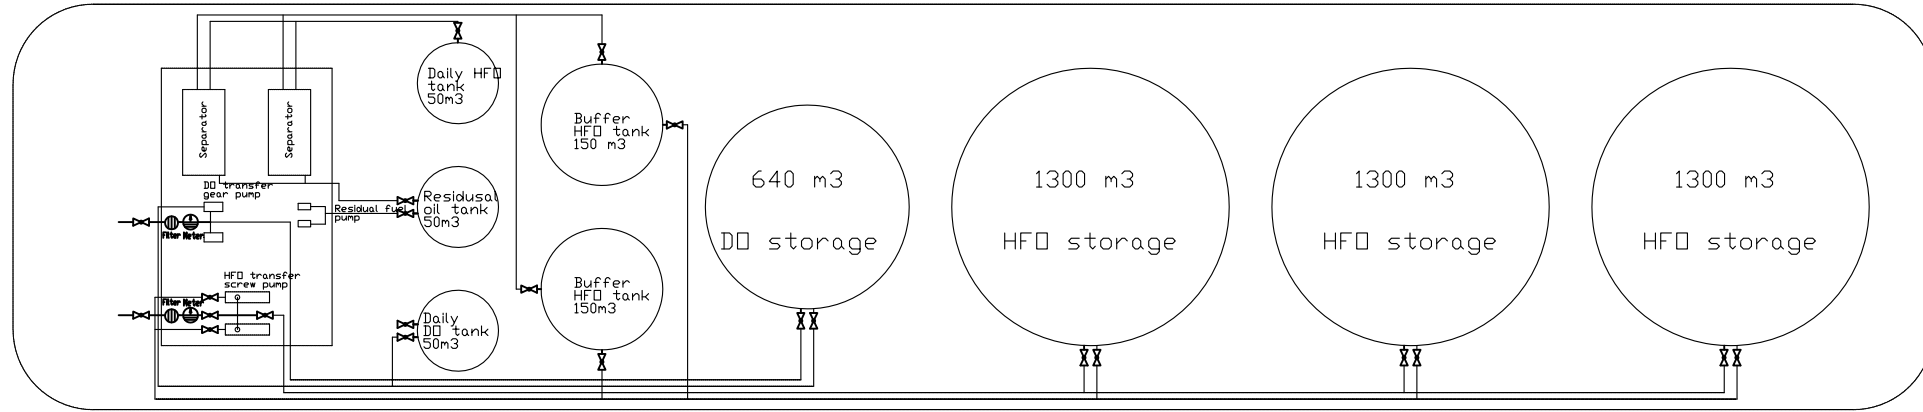

SCALE	1:150	DATE		DRWN		CHK'D		APPR.		DATE		REV		DATE		BY		DATE		BY		DATE	
Leda Greenpower (Beijing) Trading & Engineering Co., Ltd.																							
NAME Layout for 12X3MW HFO Power Plant																							
MATERIAL																							
DRAWING NO. PF-01-01R																							